




DO NOT SCALE

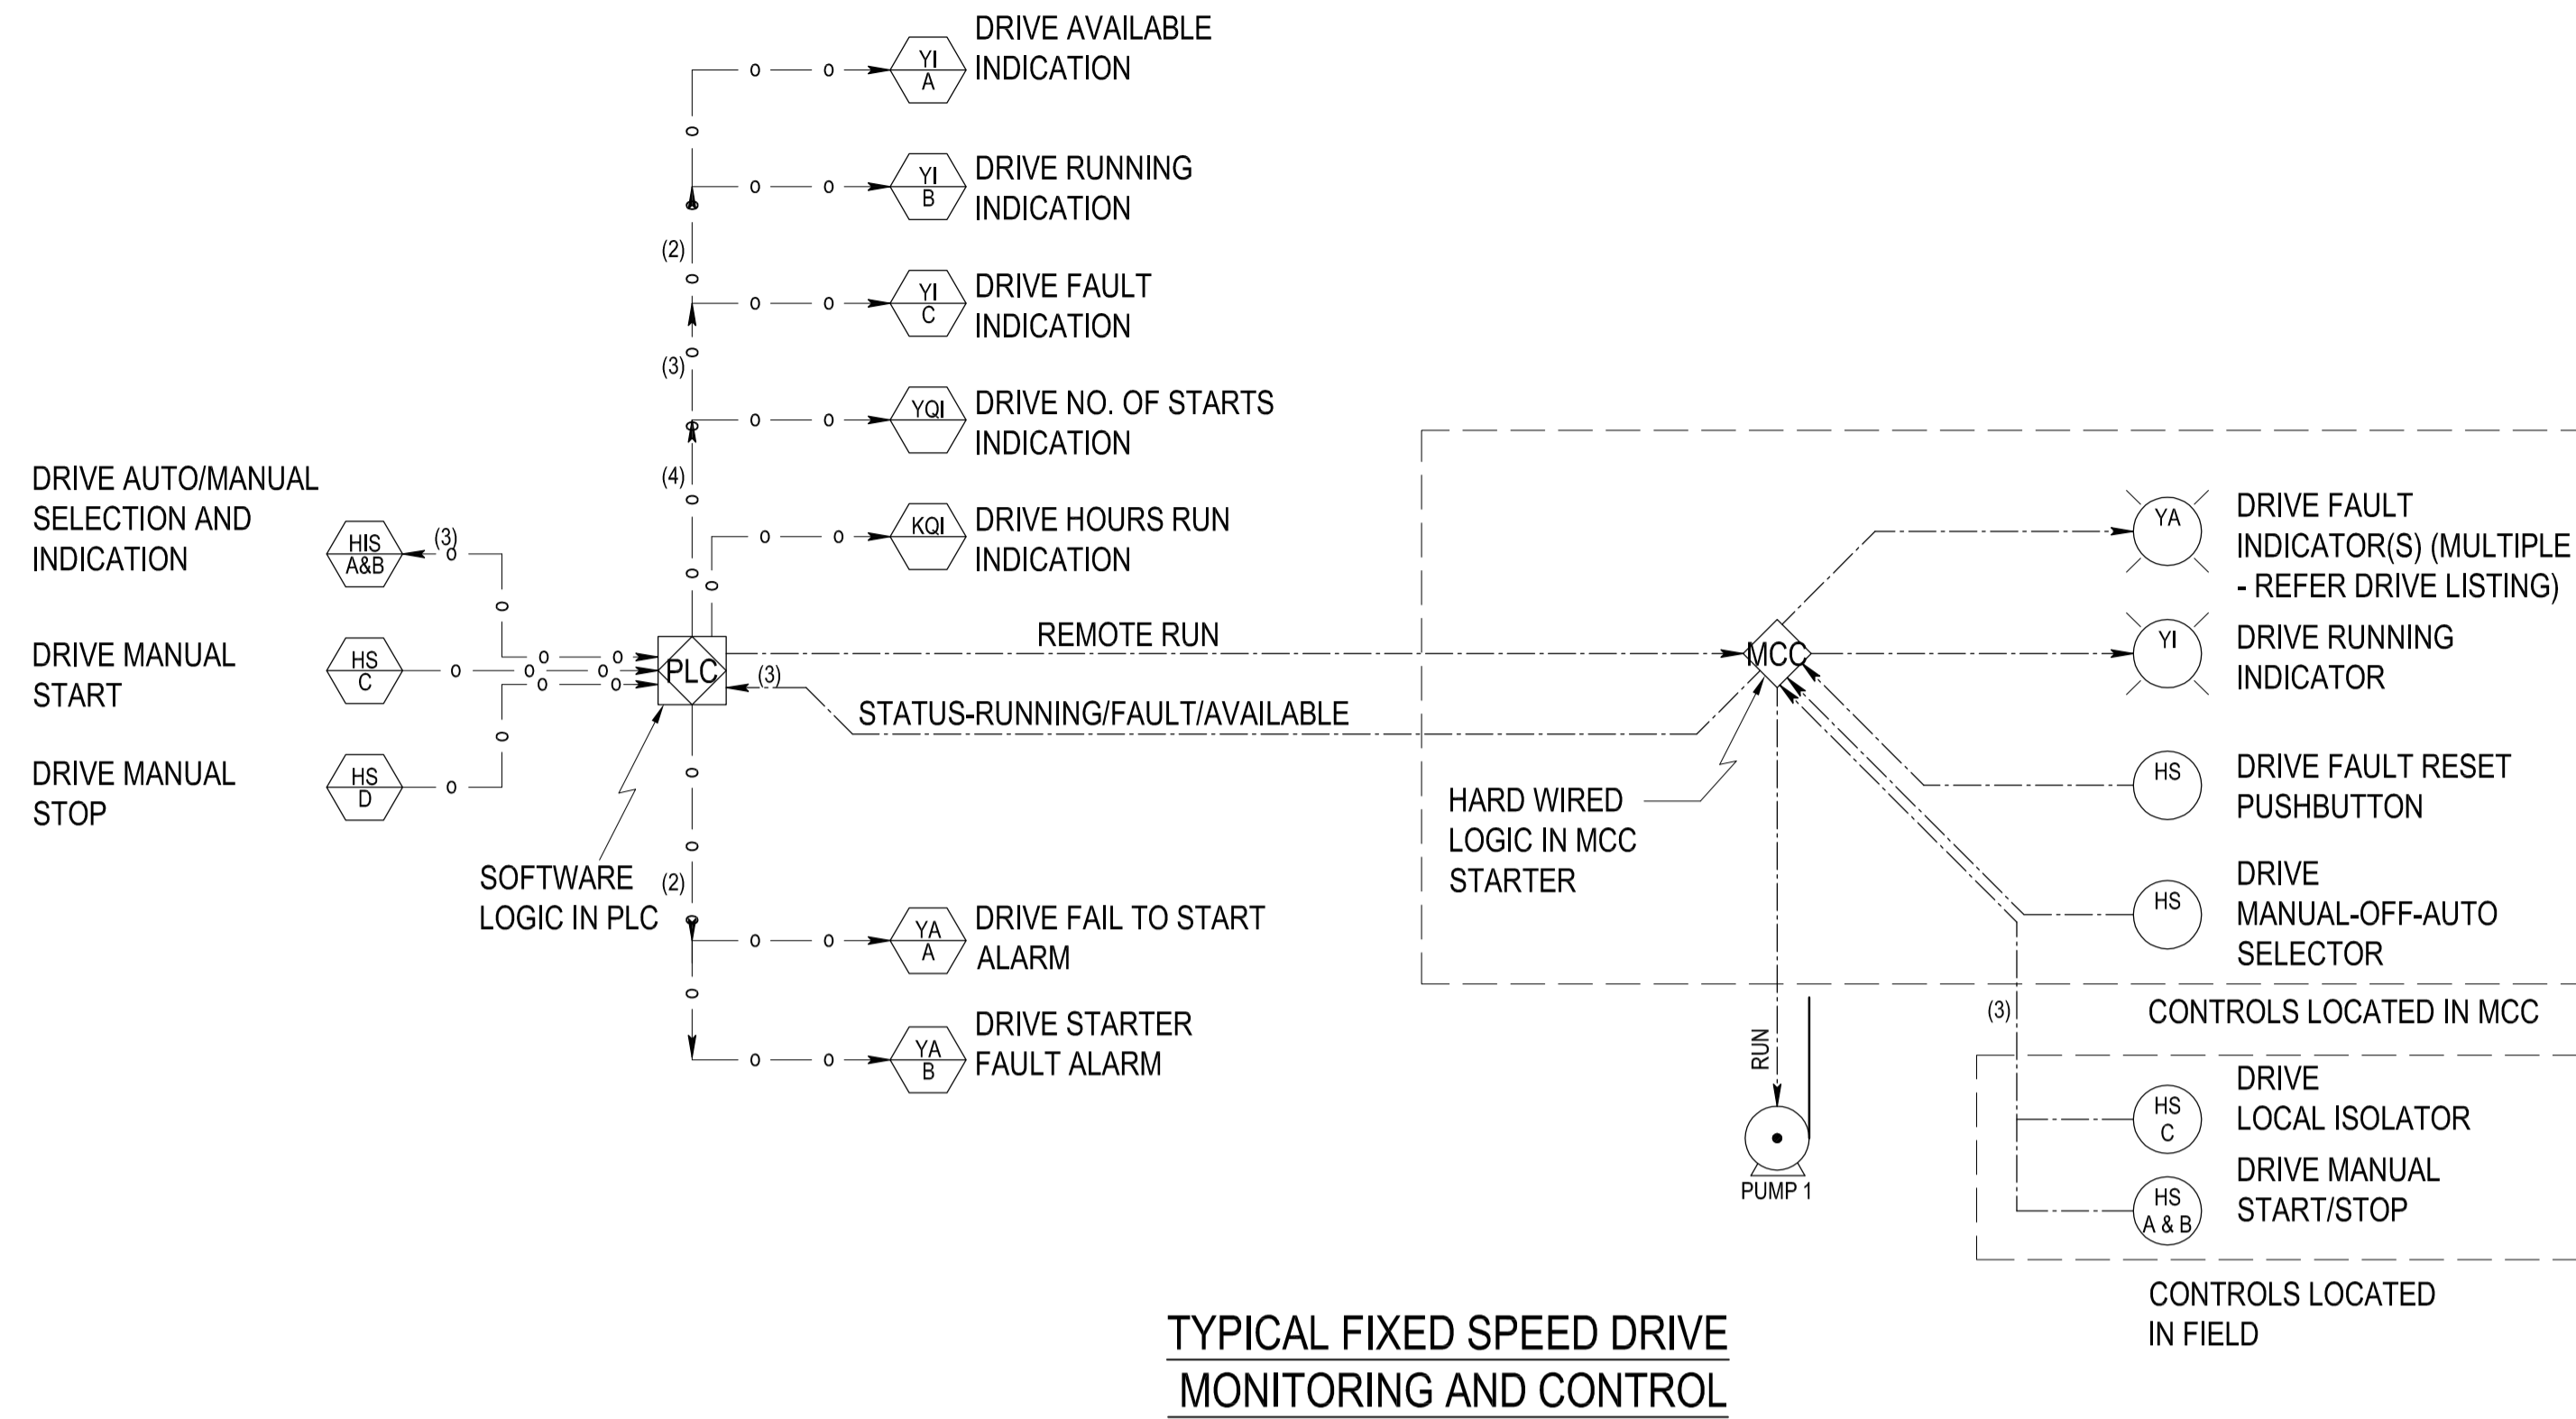


TYPICAL FIXED SPEED DRIVE MONITORING AND CONTROL

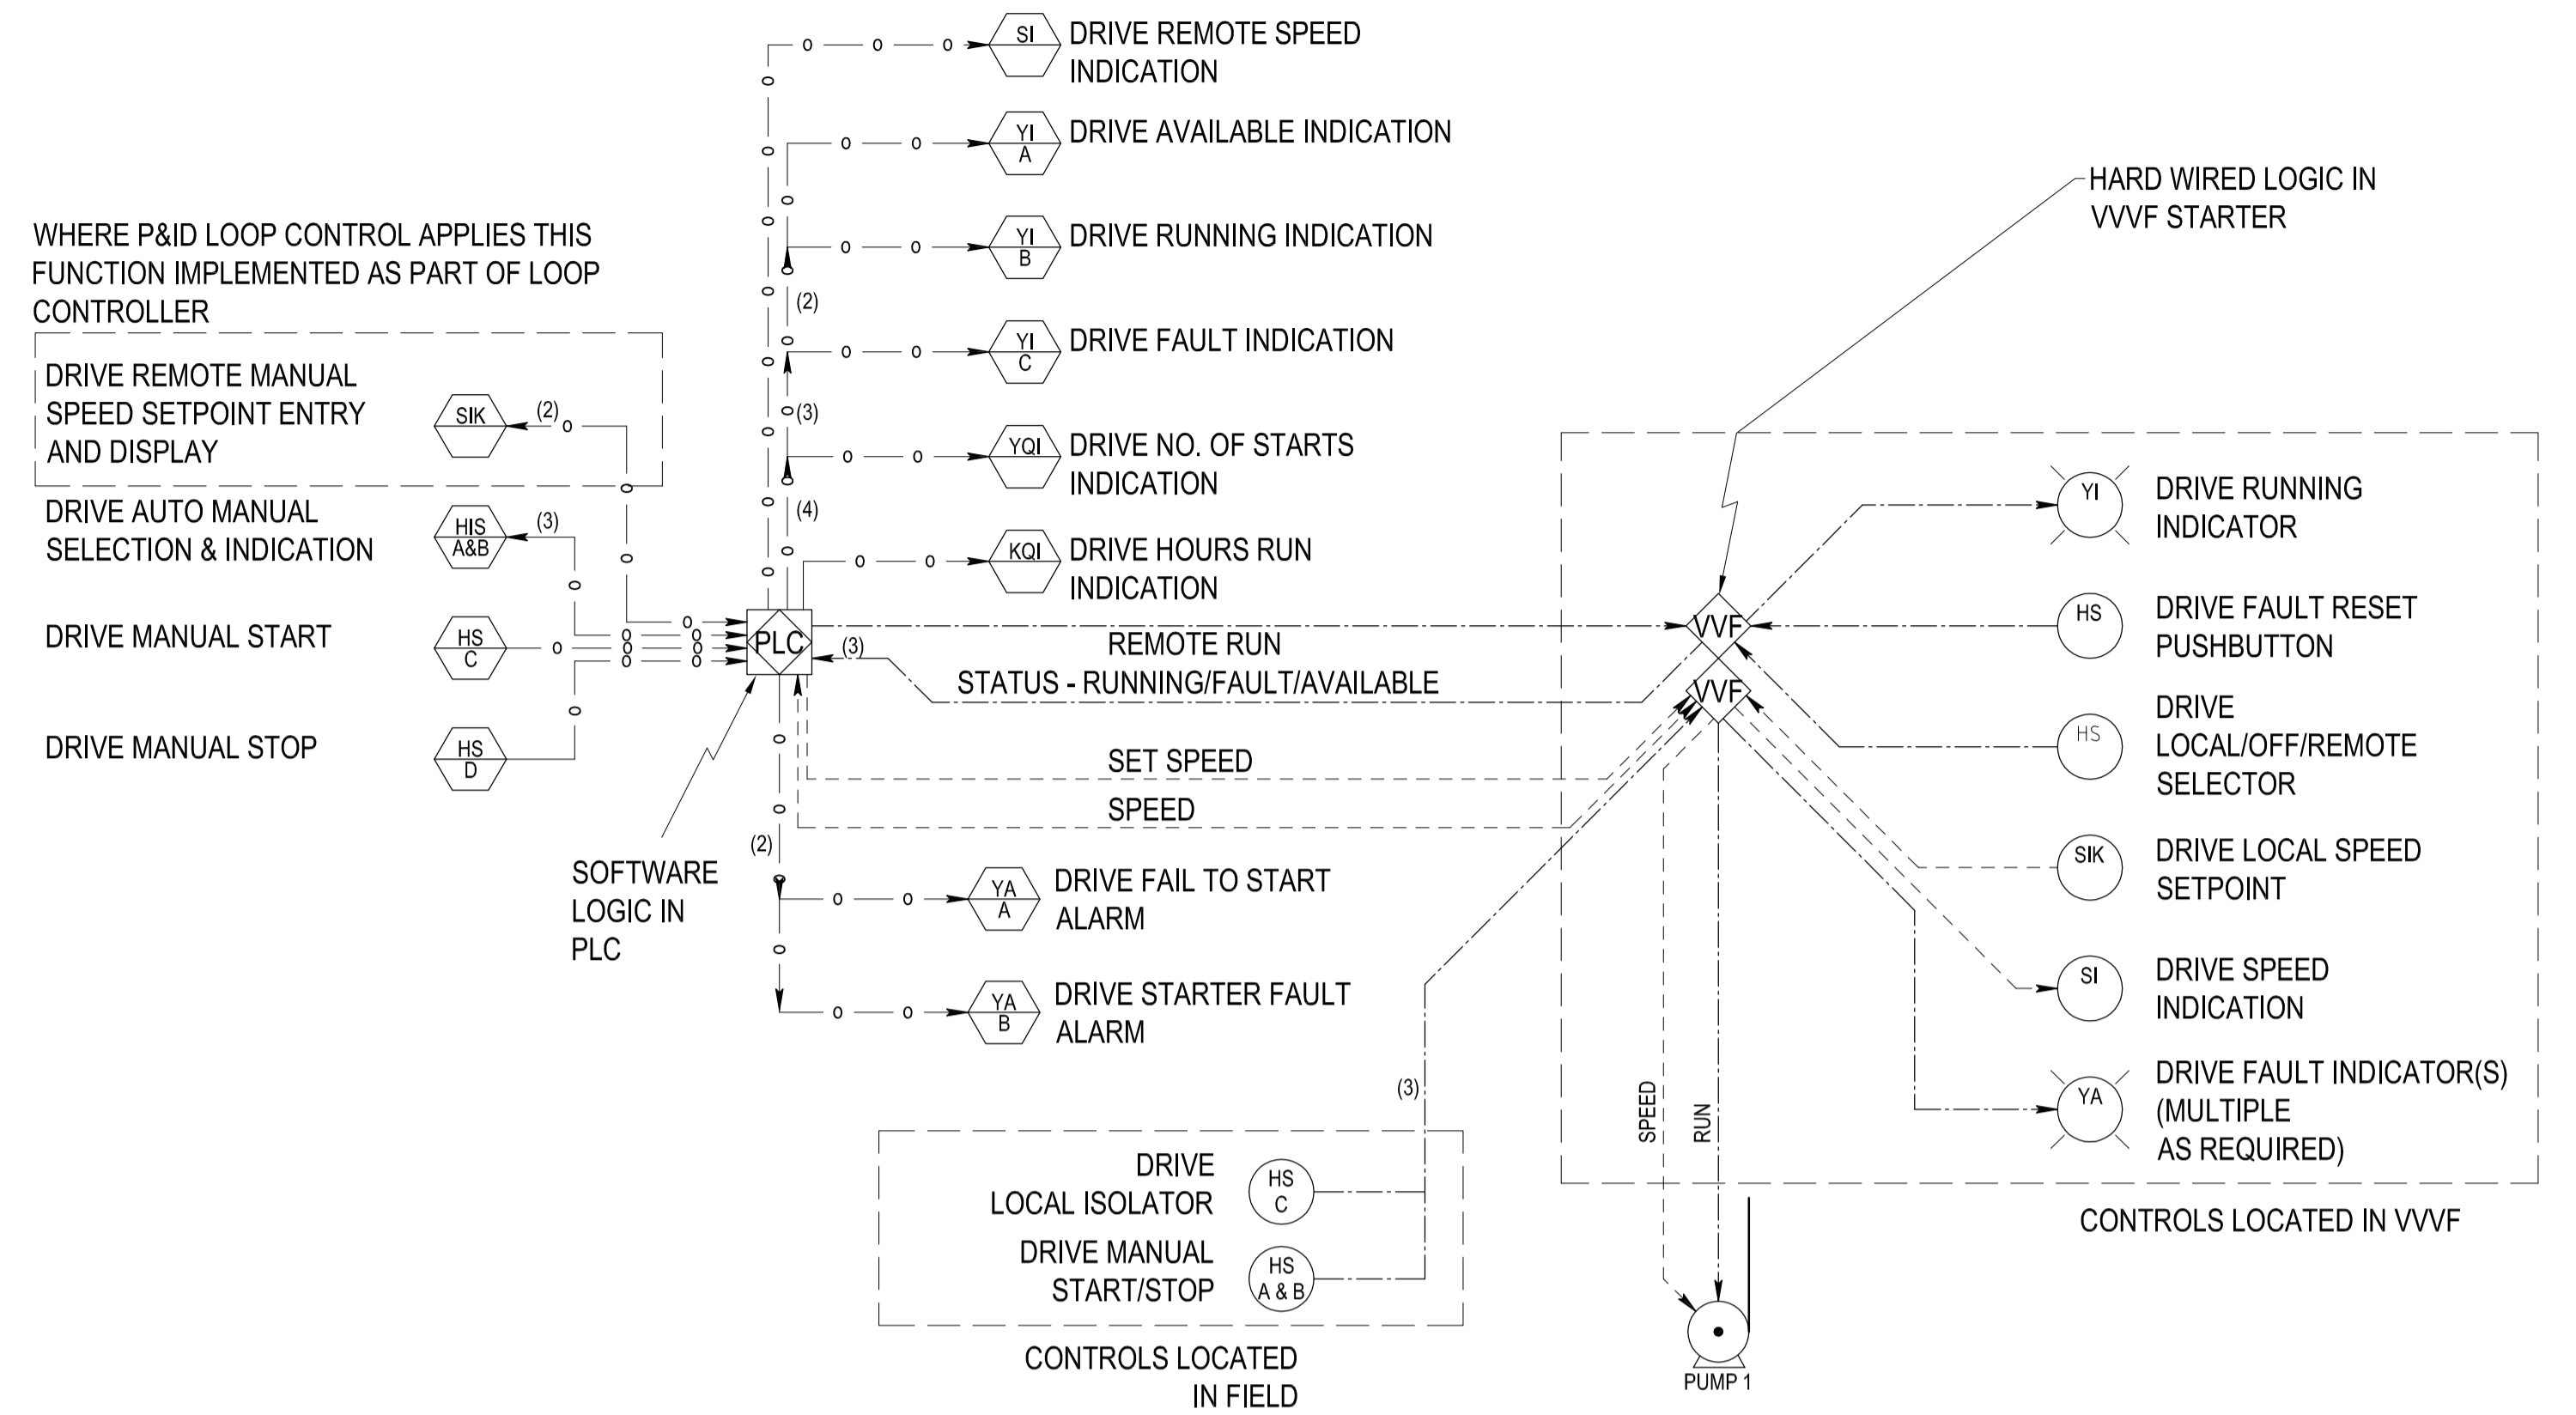

TYPICAL VARIABLE SPEED DRIVE MONITORING AND CONTROL

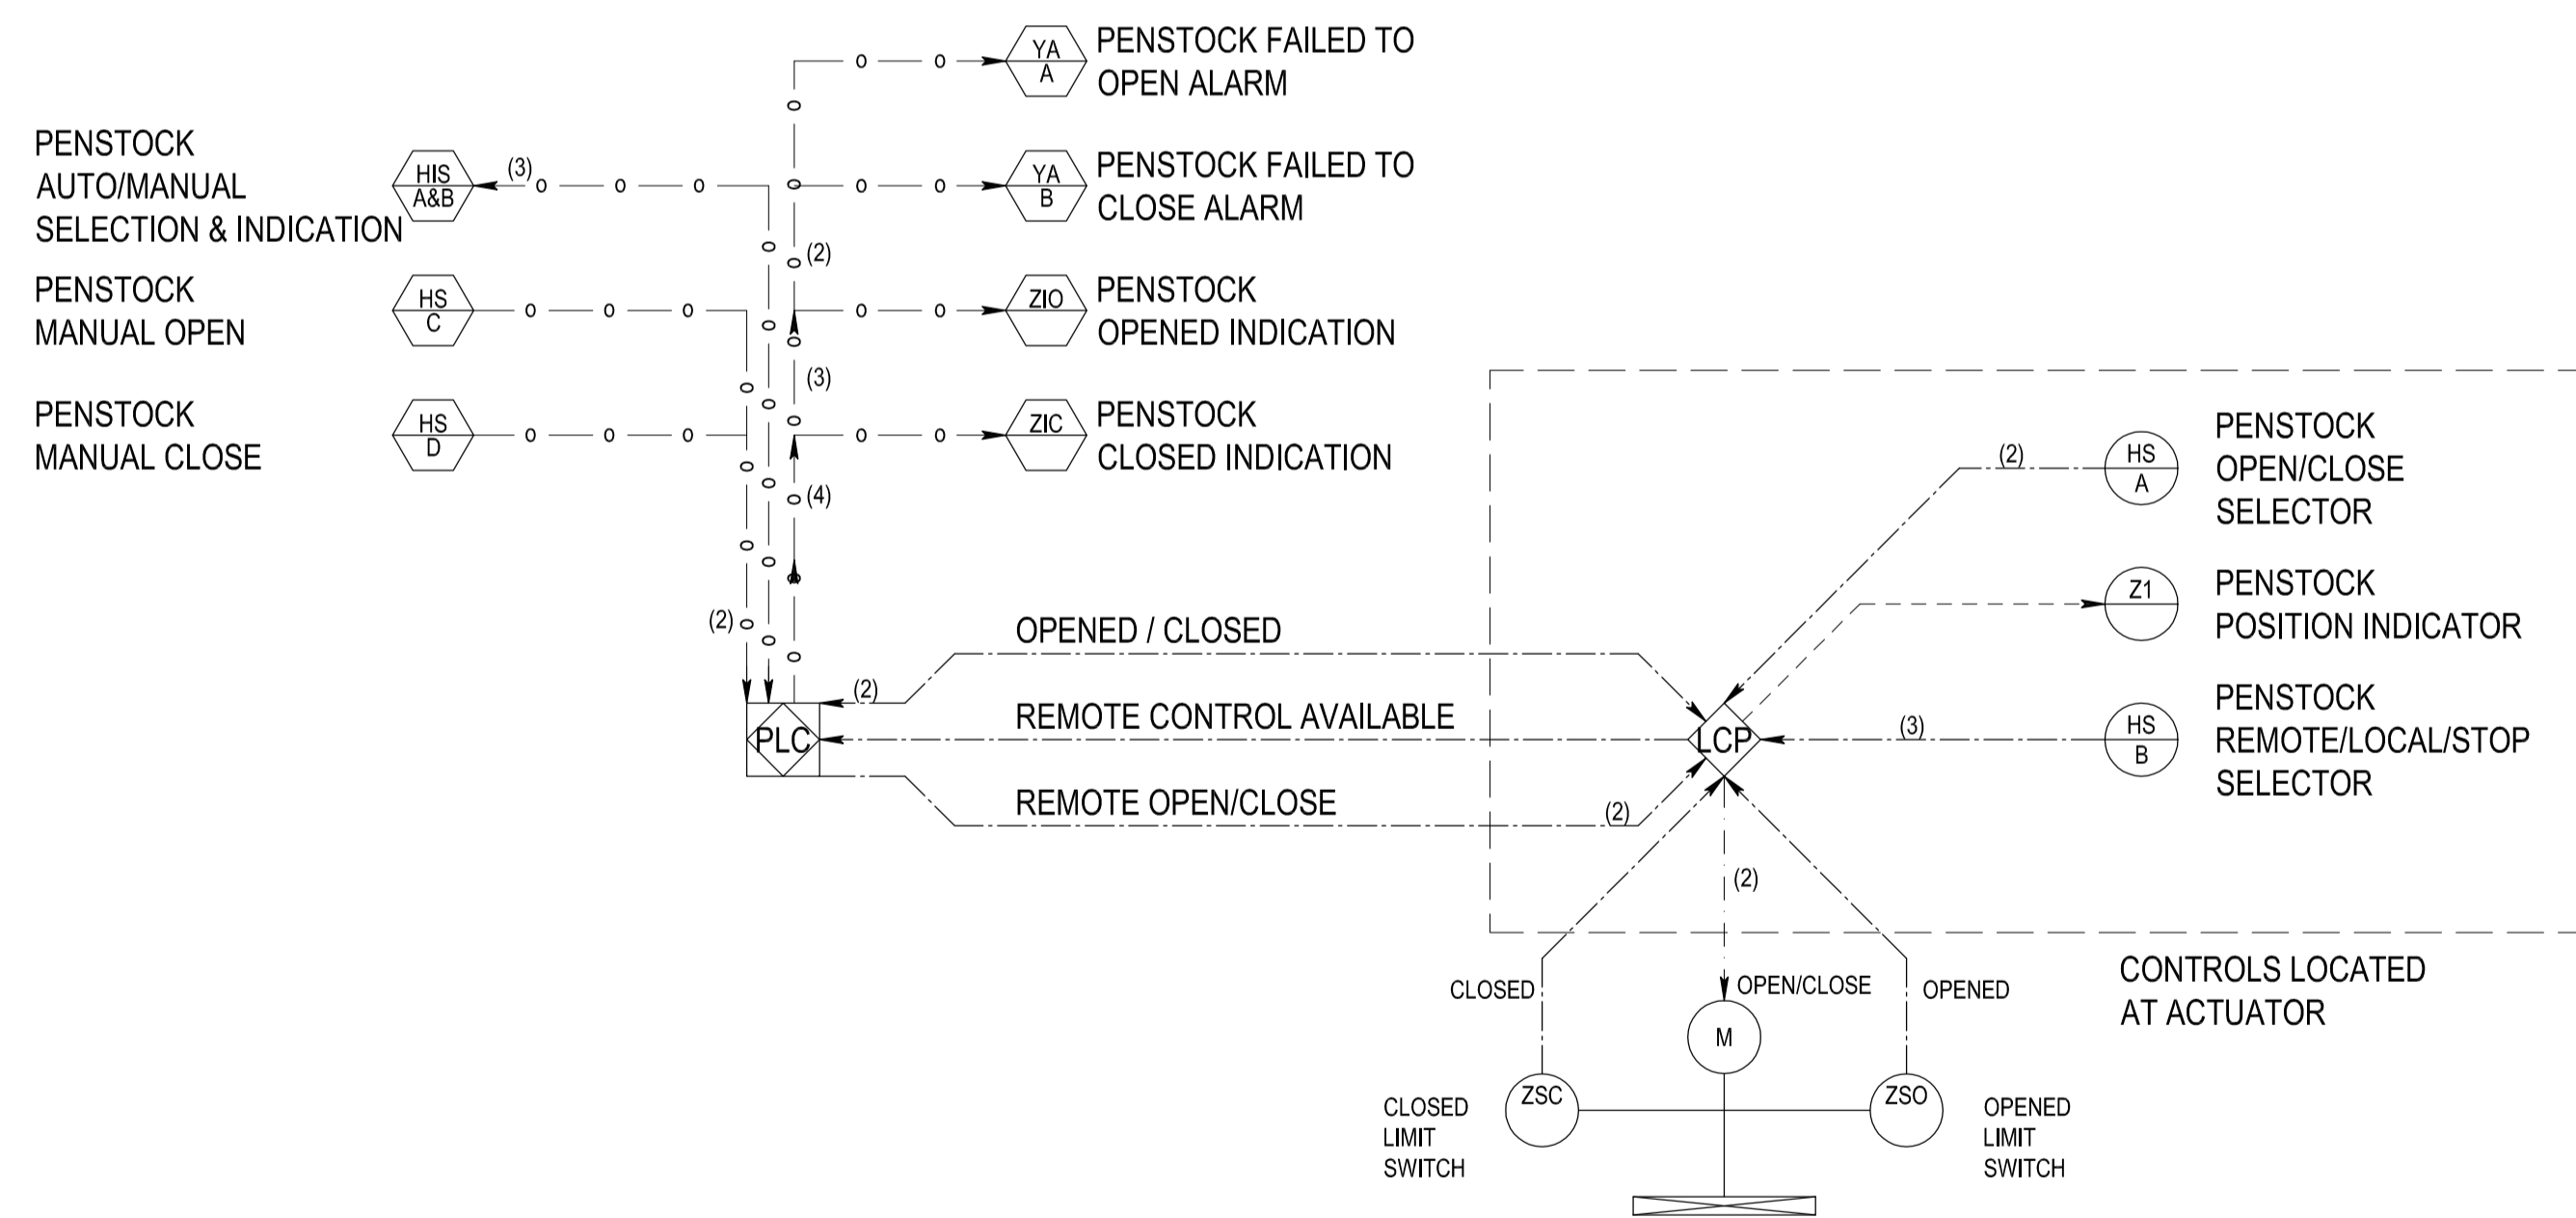

TYPICAL OPEN/CLOSE PENSTOCK MONITORING AND CONTROL

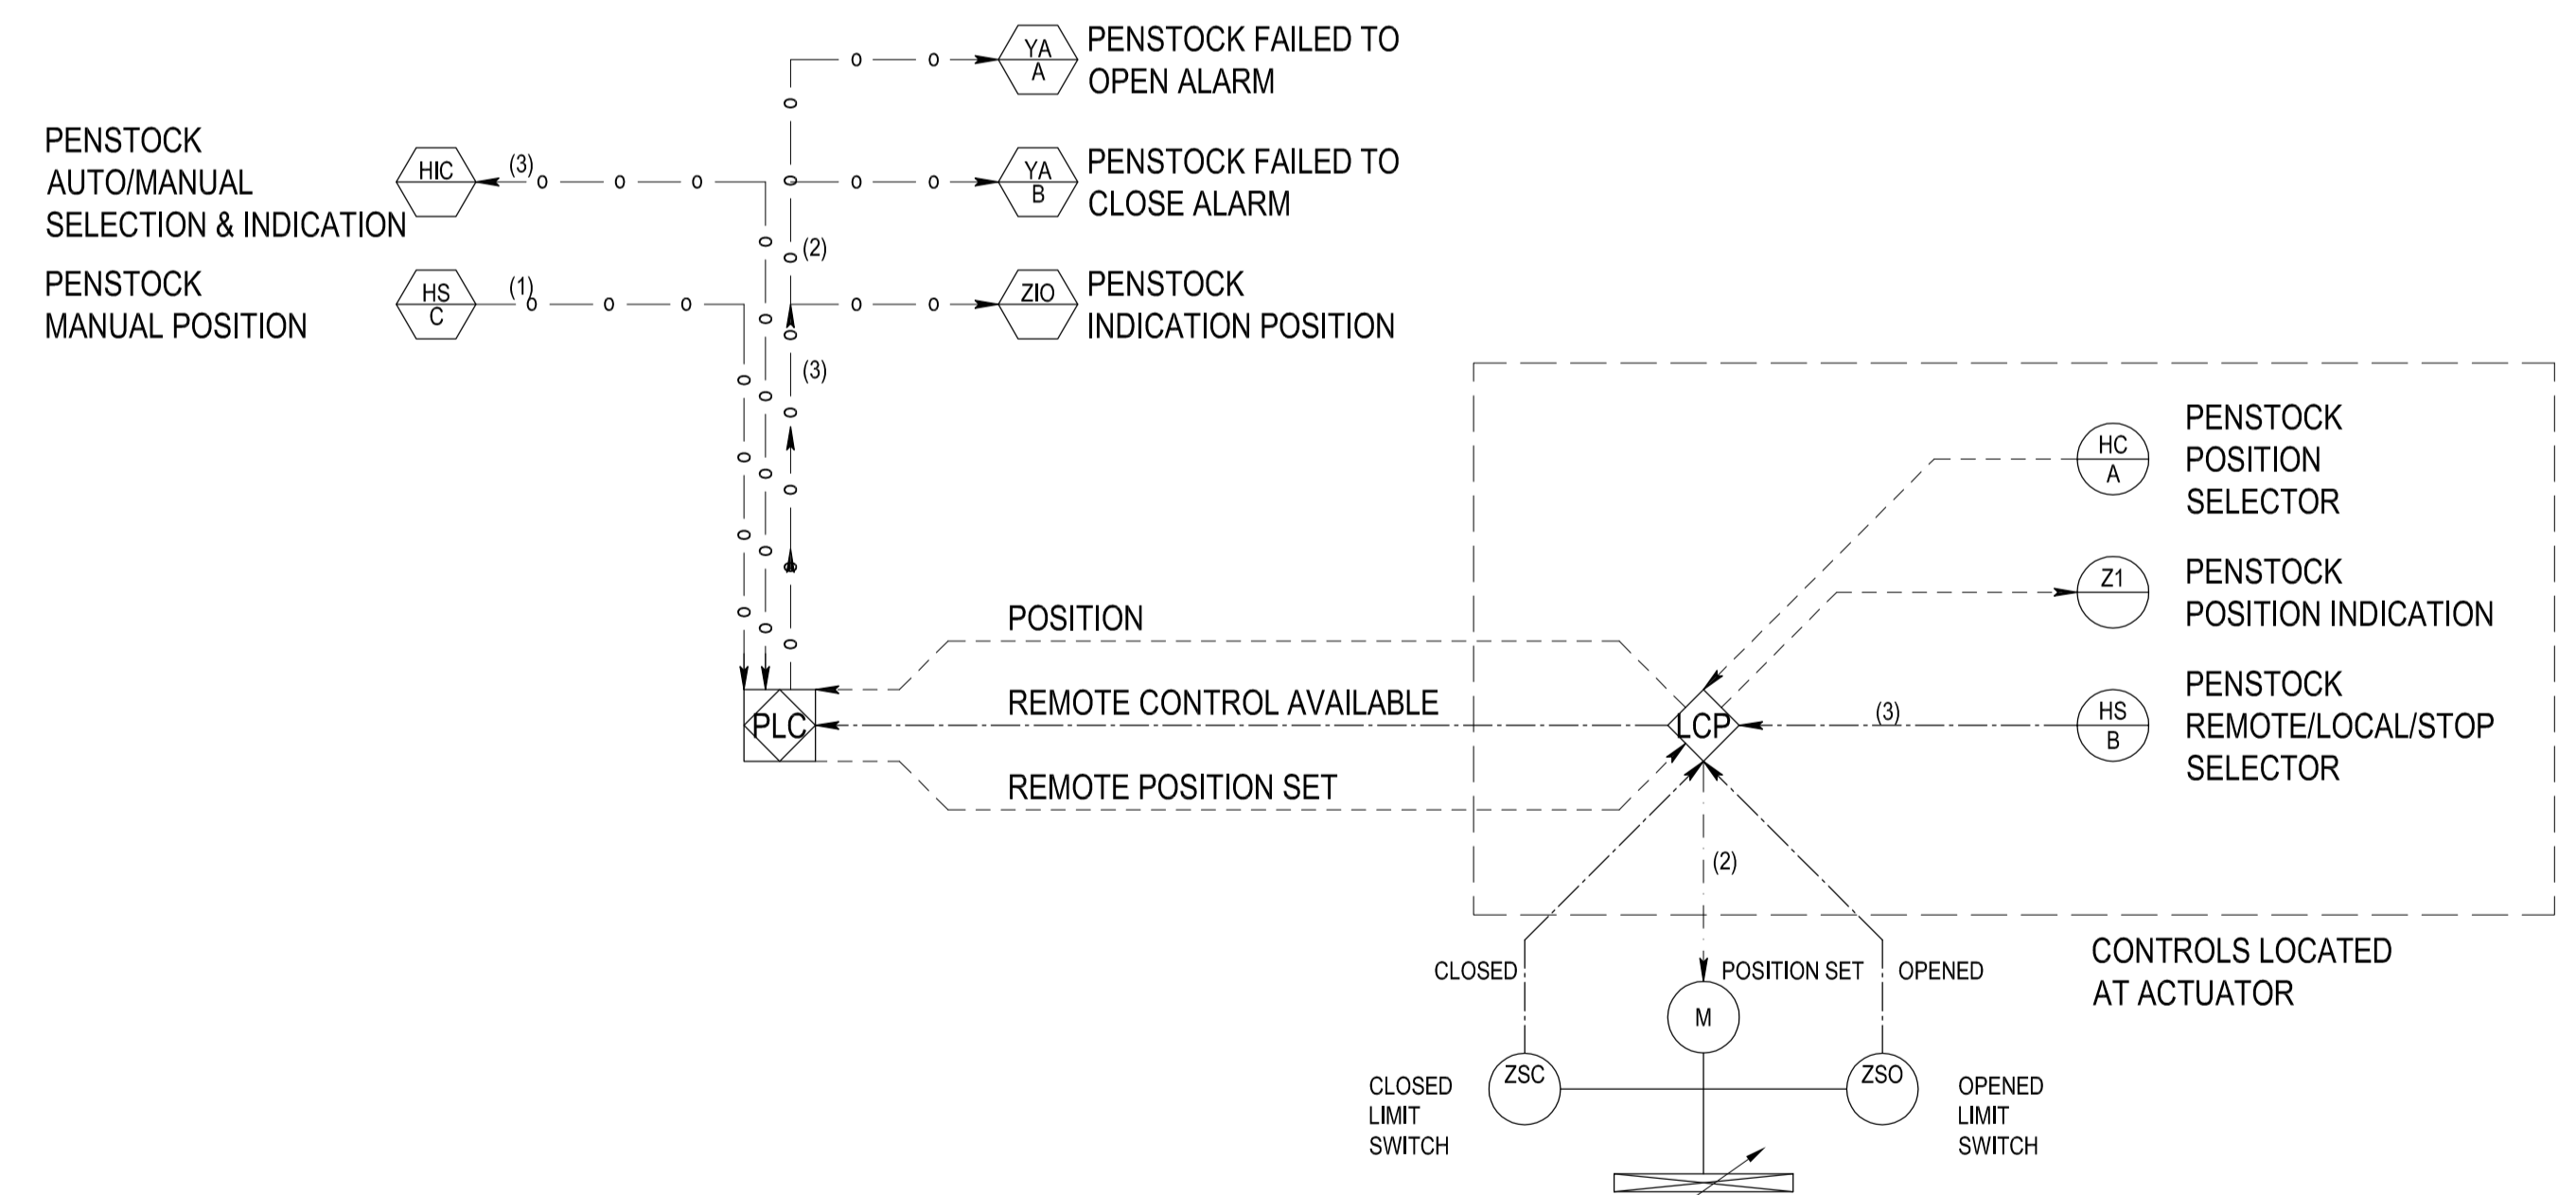

TYPICAL MODULATING PENSTOCK MONITORING AND CONTROL

STANDARD DRAWING

REFERENCES		REVISIONS							
DRAWING	TITLE	No.	REVISION DESCRIPTION	OPS	OPS DATE	DRAWN	CHECKED	APPROVED	DATE
J001		0	ISSUED FOR USE (FROM BWA-SD-J003)	-	-	-	-	PT*	11.09.14
J002									



DRG No. BW-SD-J003

DRAWING DISCIPLINE: CIVIL AND SURVEY SHEET NO. 1 of 1

BARWON WATER - STANDARD DRAWING  
P&ID  
MONITORING & CONTROL SCHEMATIC

DRAWN	DESIGNED	APPROVED	SCALES:
R.MARRIOTT 13.05.10	G.BERRYMAN 13.05.10	P.THOMAS* 11.09.14	PLAN SECTION HORIZ. VERT. Scale for A1 sheet
DRAFTING CHECK L.BERON* 30.06.10	DESIGN CHECK J.VAN* 30.06.10		

FILE NO. A1